

Copyright Reserved

The Contractor shall verify and be responsible for all dimensions. DO NOT scale the drawing - any errors or omissions shall be reported to Stantec without delay.
 The Copyrights to all designs and drawings are the property of Stantec. Reproduction or use for any purpose other than that authorized by Stantec is forbidden.

Notes

UTILITIES NOTE: The position of any existing public or private sewers, utility services, plant or apparatus shown on this drawing is believed to be correct, but no warranty to this is expressed or implied. Other such plant or apparatus may also be present but not shown. The Contractor is therefore advised to undertake their own investigation where the presence of any existing sewers, services, plant or apparatus may affect their operations.

- All dimensions are in millimetres unless noted otherwise.
- All levels are in metres relative to Ordnance Datum Newlyn unless noted otherwise.
- All coordinates are in metres relative to Ordnance Survey National Grid.
- The Contractor is to verify all dimensions on site before commencing work or preparing shop drawings.
- This drawing is to be read in conjunction with all Engineers and Architects drawings and specifications.

RO	SL	2023.09.21
DF	-	TB
Dwn.	Dsgn.	Chkd.

Issue Status

PLANNING APPROVAL

This document is suitable only for the purpose noted above. Use of this document for any other purpose is not permitted.

Client/Project Logo



Client/Project
 NORFOLK COUNTY COUNCIL



SHERINGHAM RECYCLING CENTRE

Title
 PROPOSED DRAINAGE LAYOUT

Project No. 49868	Scale 1:250 @ A2
Revision P08	Drawing No. 49868/2001/501

Key

- SITE BOUNDARY
- PROPOSED SURFACE WATER DRAINAGE
- PROPOSED DRAINAGE GULLY AND PIPE CONNECTION
- PROPOSED FOUL DRAINAGE AND MANHOLE
- PROPOSED FOUL SEPTIC TANK
- MONITORING POINT
- PROPOSED SOIL VENT PIPE
- PROPOSED GABION BASKET RETAINING WALL
- KERB BREAK
- INFILTRATION TRIAL PIT LOCATION
- CONCRETE SLAB PROTECTION
- RAIN GARDEN

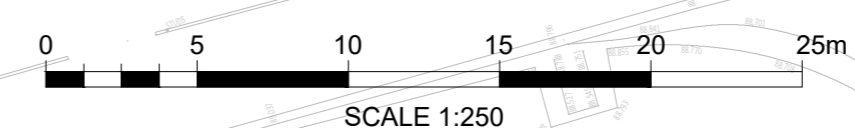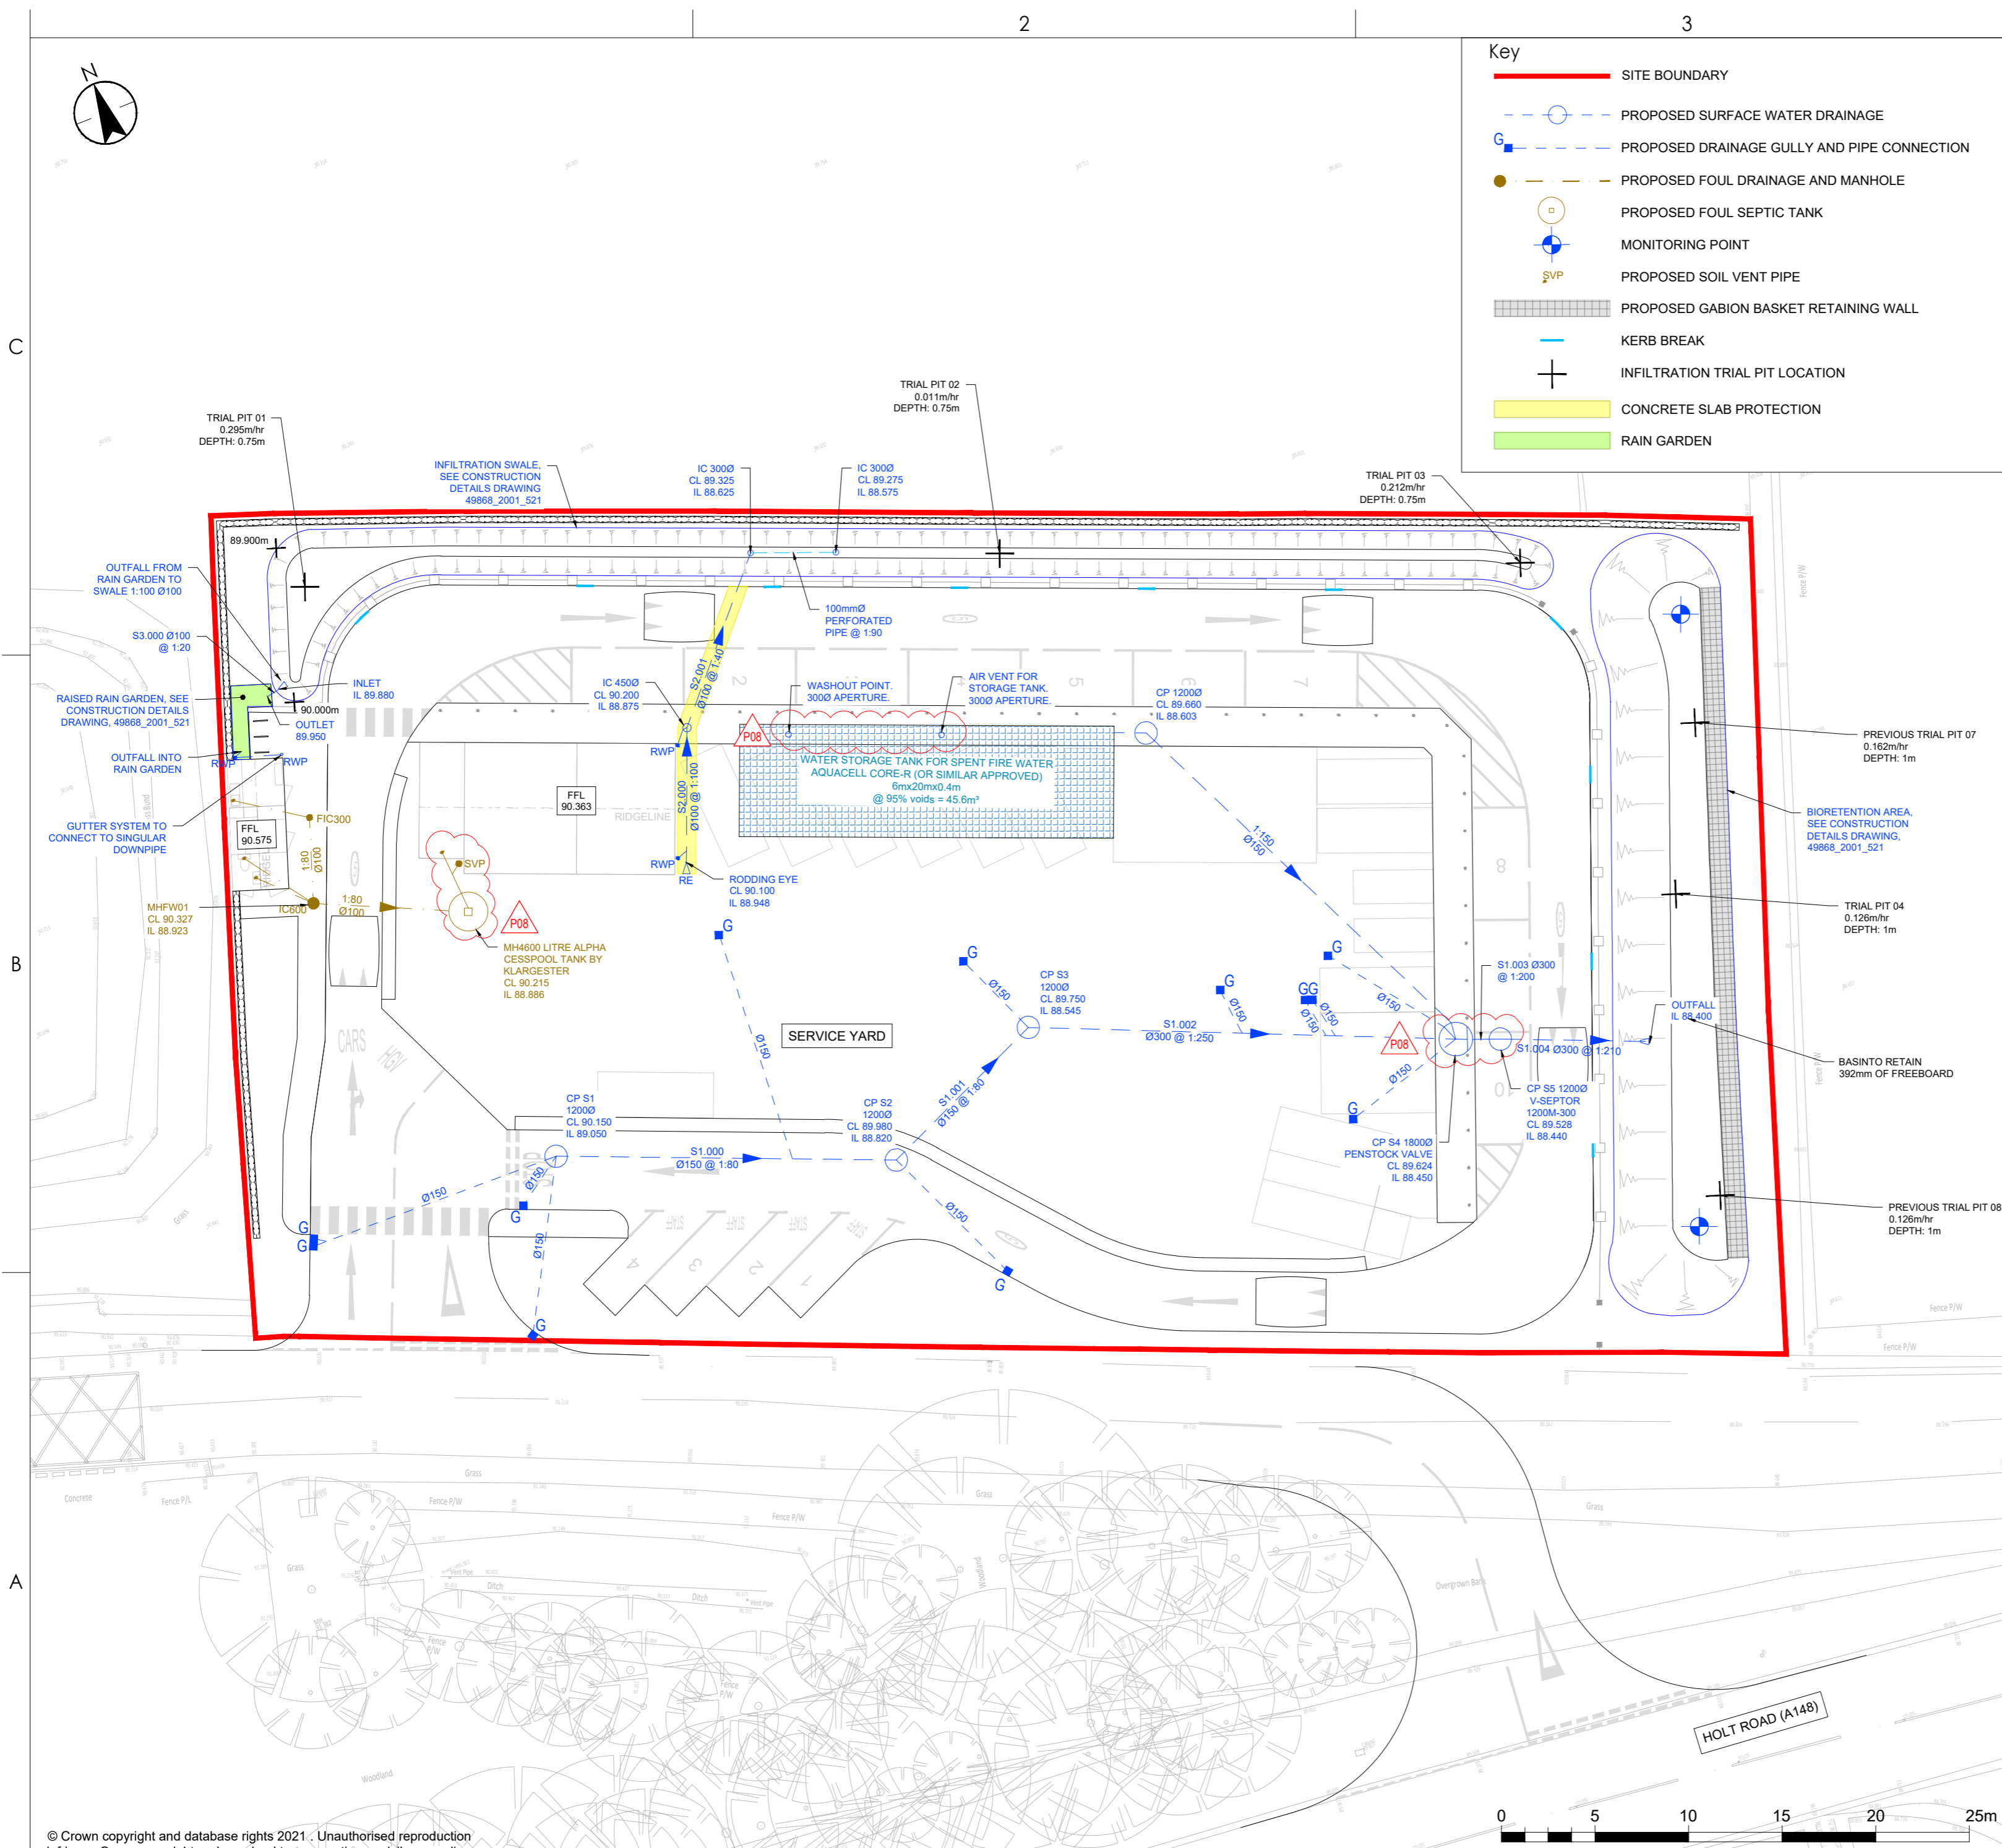

Plotted: 14.11.2023 11:49:11:26 AM By: O Callaghan, Rhys
 ORIGINAL SHEET - SOA2 \\cam-vfp-001\cam\projects\9868\sheringham\recycling\centre\cod\dwg\p\2001_cnv\9868_2001_501 - drainage layout